


PLAN NORTH
 FLOOR PLAN
 SCALE: 1/4" = 1'-0"

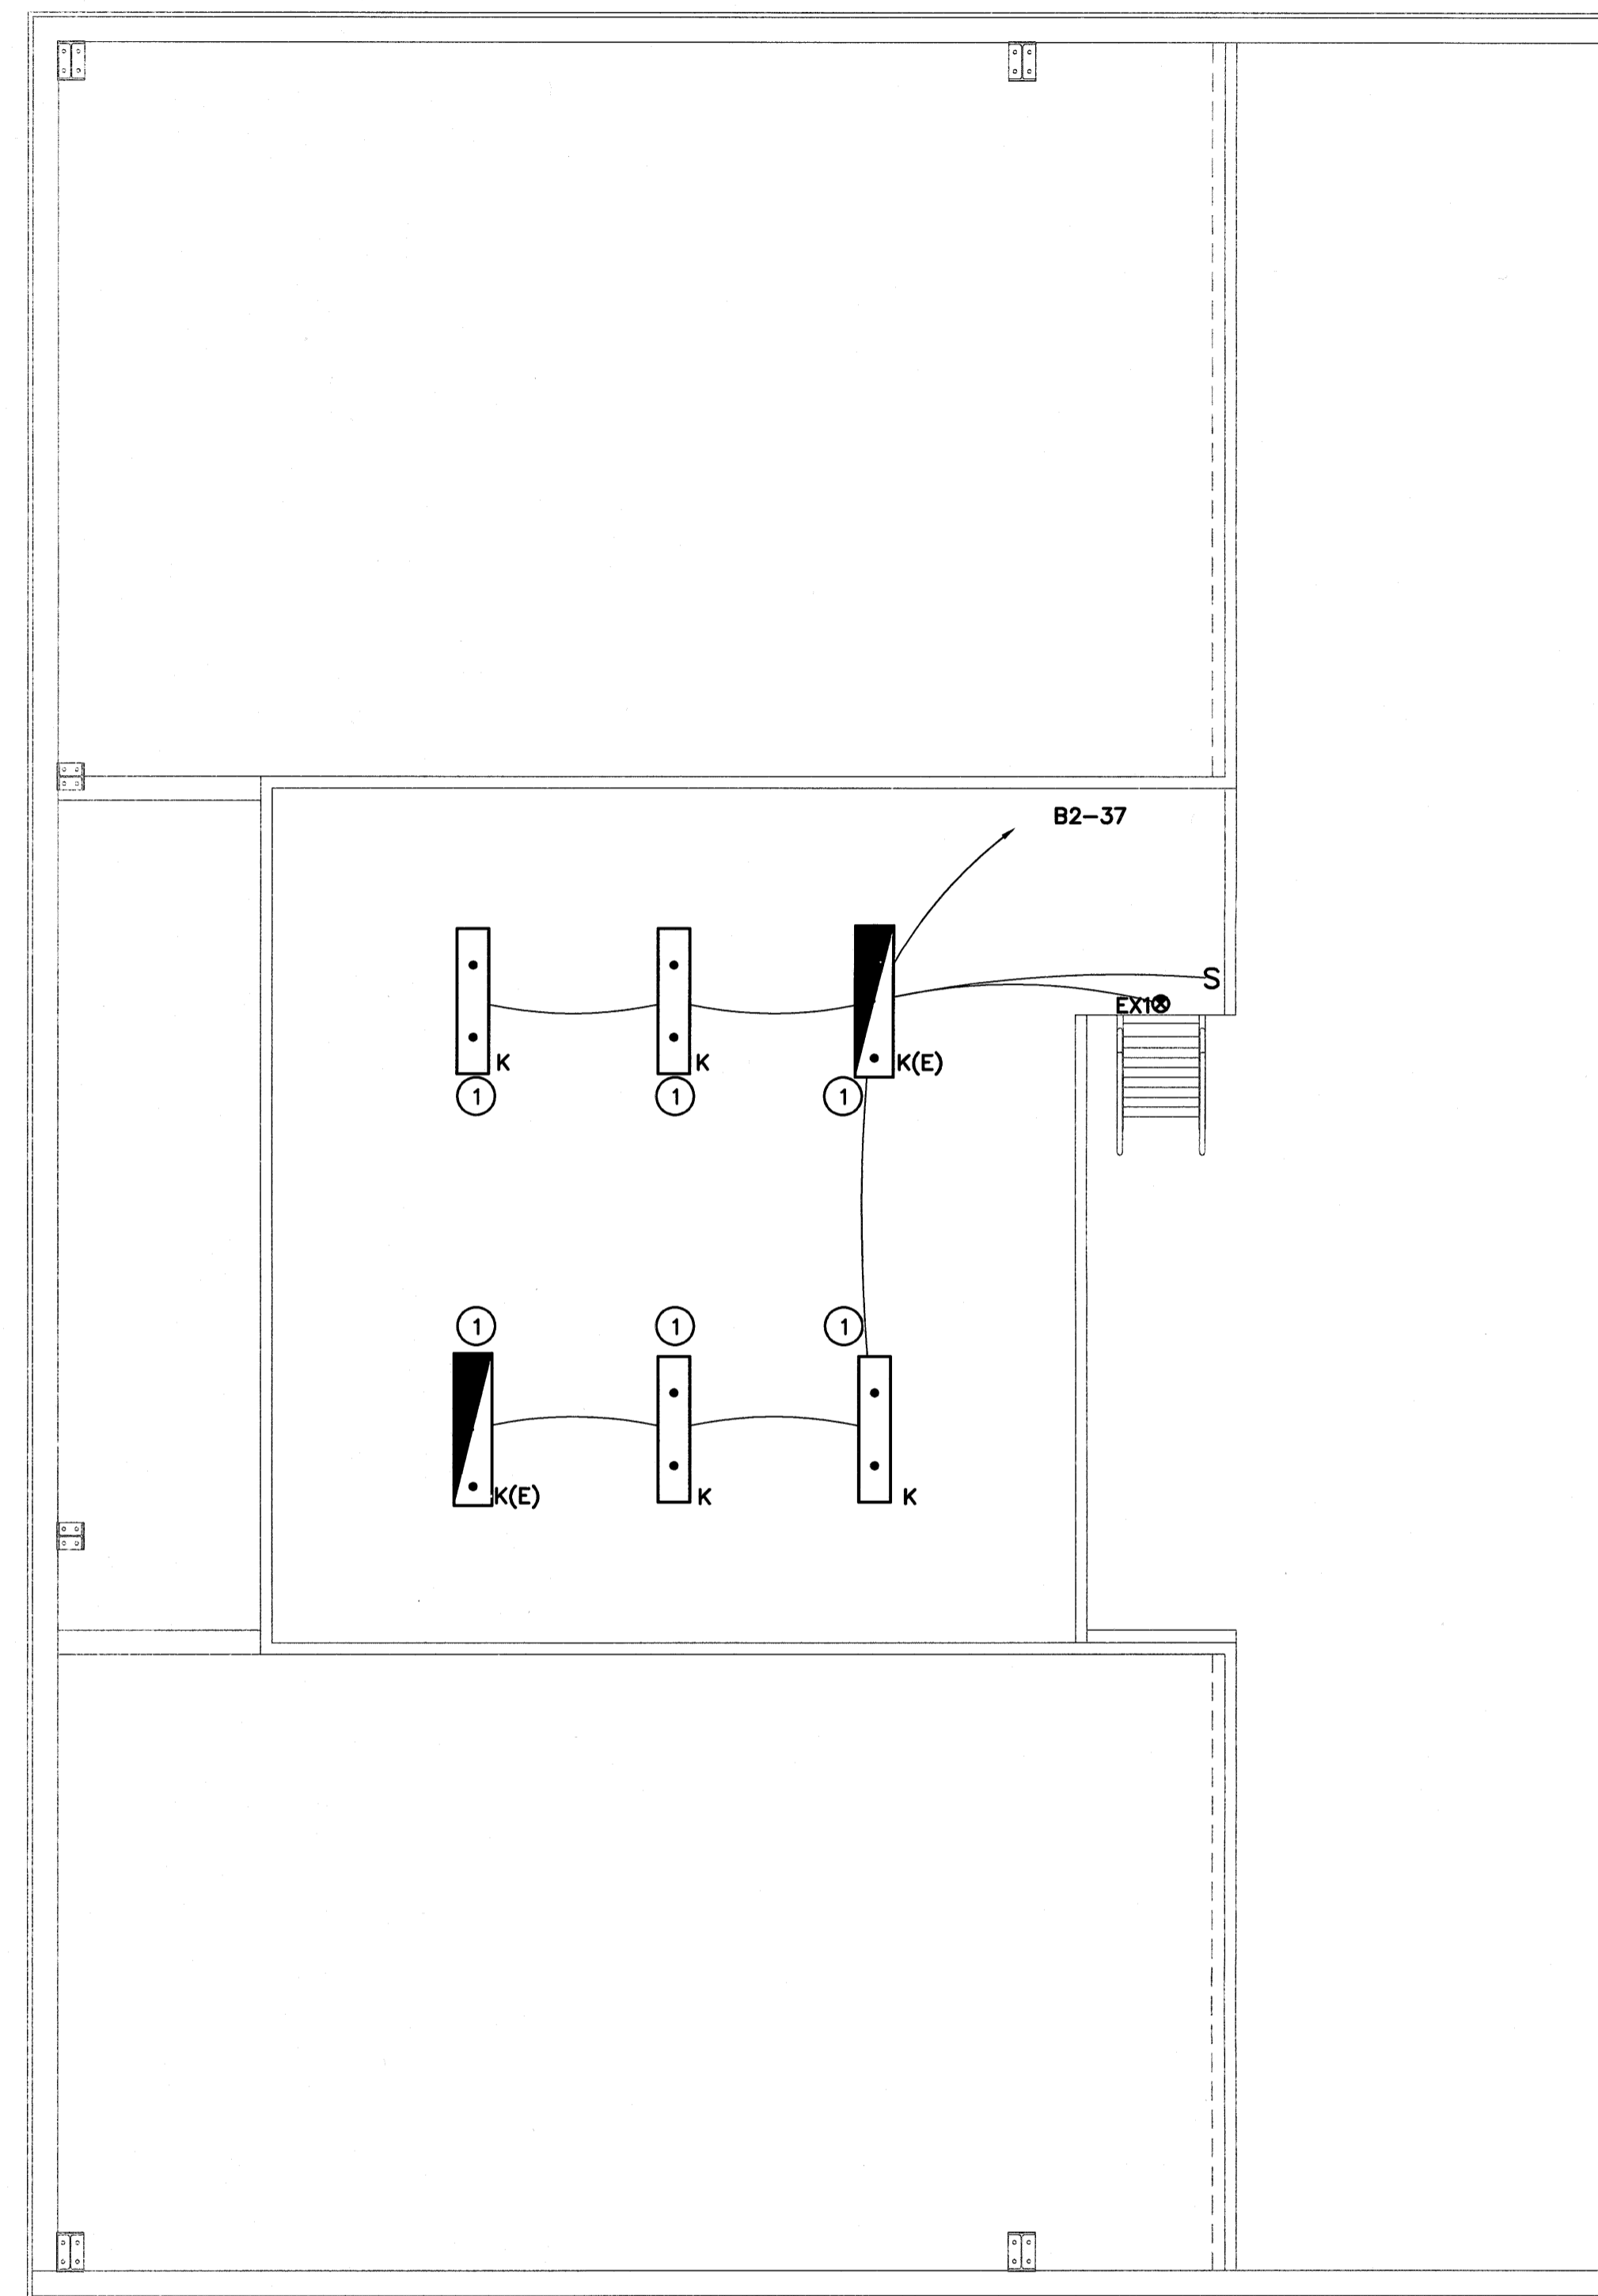

PLAN NORTH
 FLOOR PLAN
 SCALE: 1/4" = 1'-0"

ELECTRICAL CONSTRUCTION NOTES

(APPLIES TO THIS DRAWING ONLY)

1	LOCATE FIXTURE TYPES K AND K(E) 7'-6" A.F.F.	6	
2		7	
3		8	
4		9	
5		10	

MARCUM ENGINEERING, LLC
 500 SOUTH 17th STREET - PADUCAH, KENTUCKY 42002-0120
 PHONE - 270.444.9274 FAX - 270.443.1904
COPYRIGHT © 2010 MARCUM ENGINEERING, LLC

castleberry megregor swinford ARCHITECTS
 BENTON GAS SYSTEM
 Project No. 10560

ELECTRICAL MEZZANINE PLAN - BLDG. B

E-6
 of 13

DATE
 10/01/10