

**COMMONWEALTH OF KENTUCKY
DEPARTMENT FOR FACILITIES AND SUPPORT SERVICES
DIVISION OF ENGINEERING AND CONTRACT ADMINISTRATION**

INVITATION TO BID NO: RFB-156-12

DATE: January 31, 2012

FOR: Sprinkler System & Building Renovations
Western State Hospital
Hopkinsville, Kentucky

ADDENDUM NO.: Four (4)

BIDDER SHALL CONFORM TO THE FOLLOWING CHANGES AS SAME SHALL BECOME BINDING UPON THE CONTRACT TO BE ISSUED IN RESPONSE TO THIS INVITATION TO BID.

Item #1: Change the Official Bid Opening date to read as follows; February 7, 2012 at 2pm.

Item #2: Refer to attached small drawings AD3.2, AD3.3 and AD3.4.

Refer to hardcopy addendum to be distributed by Lynn Imaging for all additions, deletions, and/or changes to specifications and/or drawings.

 
 

 



END OF ADDENDUM #4

Invitation to Bid No.: RFB-156-12

For: Sprinkler System & Building Renovations
Western State Hospital
Hopkinsville, Kentucky

Michelle Noble, CPPB, Strategic Procurement Specialist I
Division of Engineering and Contract Administration

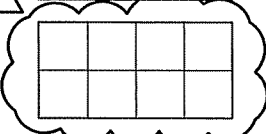REFLECTED CEILING LEGEND

	NEW 2x2 ACOUSTICAL CEILING PANELS
	2 x 2 ACOUSTICAL CEILING PANELS BENEATH PLASTER SUBSTRATE
	2 x 2 MYLAR-COATED ACOUSTICAL CEILING PANELS BENEATH PLASTER SUBSTRATE
	2 x 4 ACOUSTICAL CEILING PANELS BENEATH ACOUSTICAL CEILING TILE ADHERED WITH GLUE DOTS (NON-FIBROUS ACM ADHESIVE) OVER PLASTER SUBSTRATE
	2 x 4 ACOUSTICAL CEILING PANELS BENEATH PLASTER SUBSTRATE
	PAINTED GYPSUM BOARD OVER PLASTER SUBSTRATE
	PAINTED PLASTER SUBSTRATE

ALL CEILINGS SHALL BE REINSTALLED AT EXISTING HEIGHT FROM FINISH FLOOR WHERE POSSIBLE. CONFER WITH ARCHITECT AND OWNER REGARDING ANY DISCREPANCIES OR OBSTACLES.



NOTE: REVISION MARKS MADE TO LEGENDS ON SHEETS A5.1, A5.2, A5.3, A5.4, A6.1, A6.2, A6.3 AND A6.4

SPRINKLER INSTALLATION AND BUILDING RENOVATIONS
WESTERN STATE HOSPITAL

AD3.2

PROJECT NO. : 1026

DATE: 1-30-12



DRAWN BY: SJS

©-2008-ALL RIGHTS RESERVED



PECK FLANNERY GREAM WARREN INC.
a r c h i t e c t s

101 South 4th Street Paducah, Kentucky 42001 • www.pfgw.net • 112 North Main Elizabethtown, Kentucky 42701

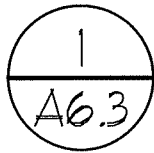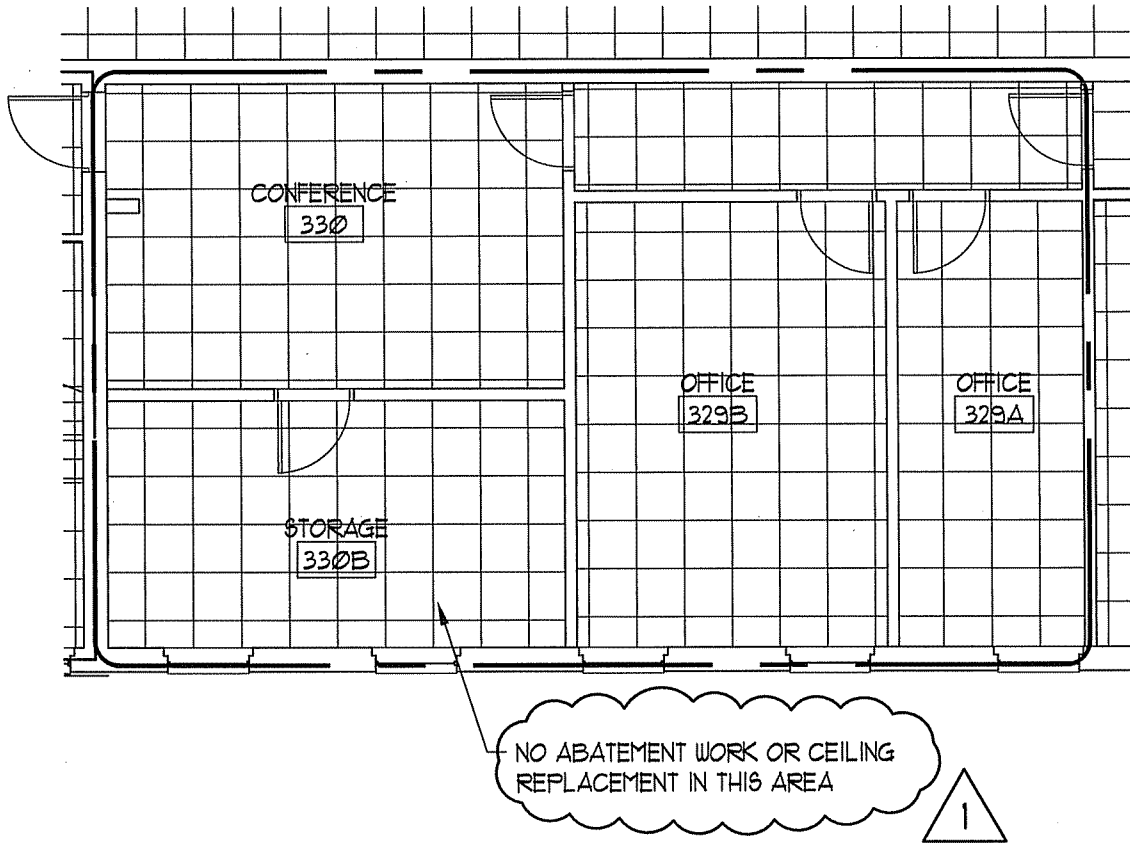

THIRD FLOOR REFLECTED CEILING PLAN - BUILDING 31

SCALE: 1/16" = 1'-0"



**SPRINKLER INSTALLATION AND BUILDING RENOVATIONS
WESTERN STATE HOSPITAL**

AD3.3
PROJECT NO.: 1026
DATE: 1-30-12
DRAWN BY: SJS
© -2008-ALL RIGHTS RESERVED



PECK FLANNERY GREAM WARREN INC.
a r c h i t e c t s

101 South 4th Street Paducah, Kentucky 42001 • www.pfgw.net • 112 North Main Elizabethtown, Kentucky 42701

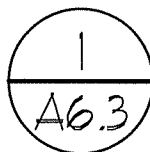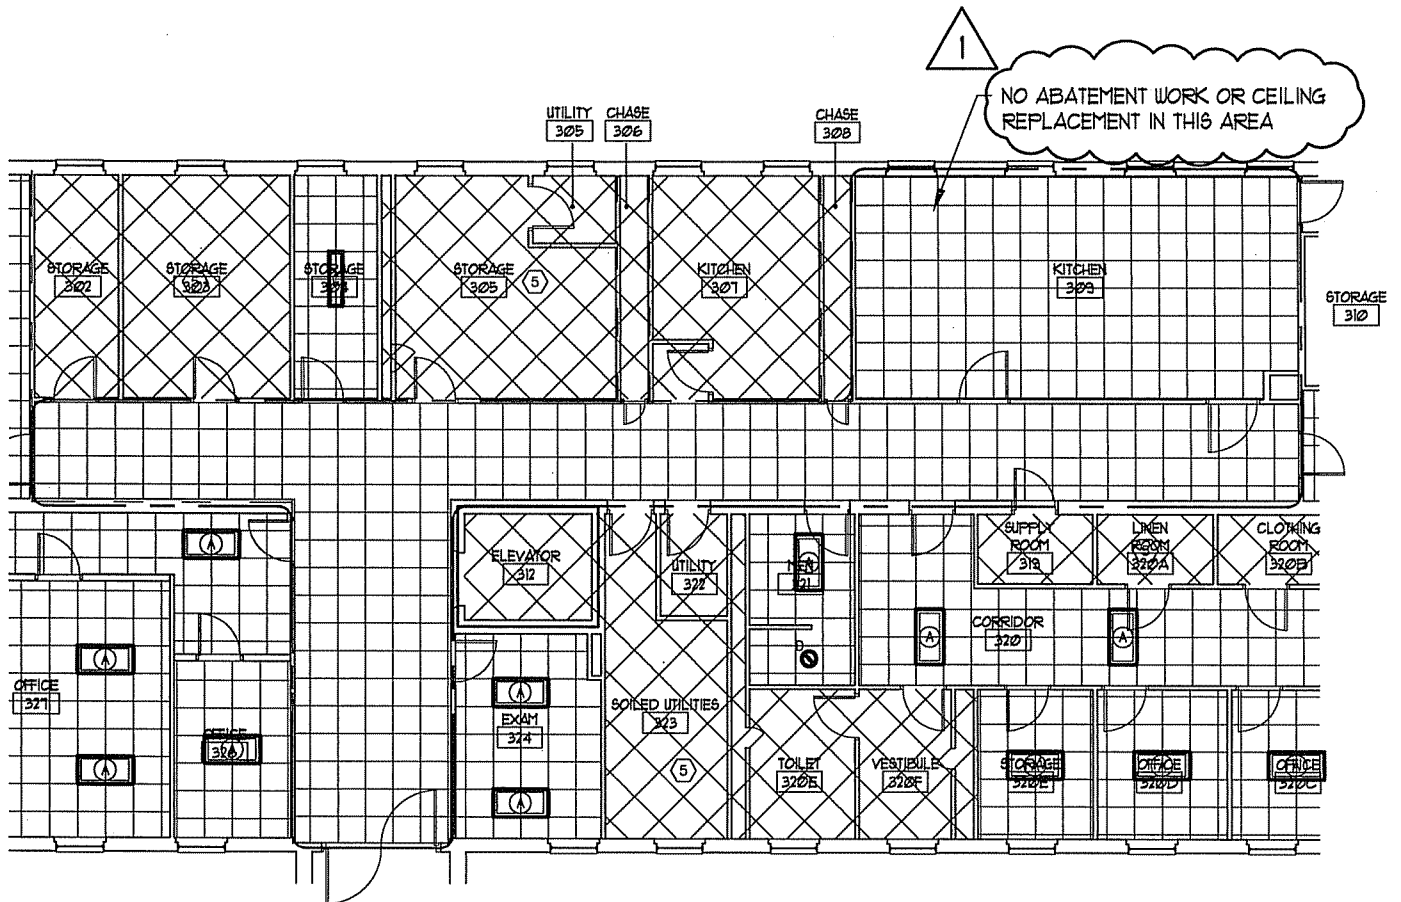

THIRD FLOOR REFLECTED CEILING PLAN - BUILDING 31

SCALE: N.T.S.

SPRINKLER INSTALLATION AND BUILDING RENOVATIONS
WESTERN STATE HOSPITAL

AD3.4

PROJECT NO. : 1026

DATE: 1-30-12

DRAWN BY: SJS

©-2008-ALL RIGHTS RESERVED



PECK FLANNERY GREAM WARREN INC.

a r c h i t e c t s

101 South 4th Street Paducah, Kentucky 42001 • www.pfgw.net • 112 North Main Elizabethtown, Kentucky 42701